


ROAD CLOSURES NOTICE


Starting date Mon 7th Dec for 2 weeks

Yellow highlighted area shows the extent of road closure whilst works are being carried out on the speedtables. **Only one** closure will be set up at a time, starting from speed table 1 and working towards speed table 4.

Residents in each particular section will still have access but they will need to drive into the closed off section so that they can enter their property without having to cross the speed table (THIS WILL BE CLOSED)

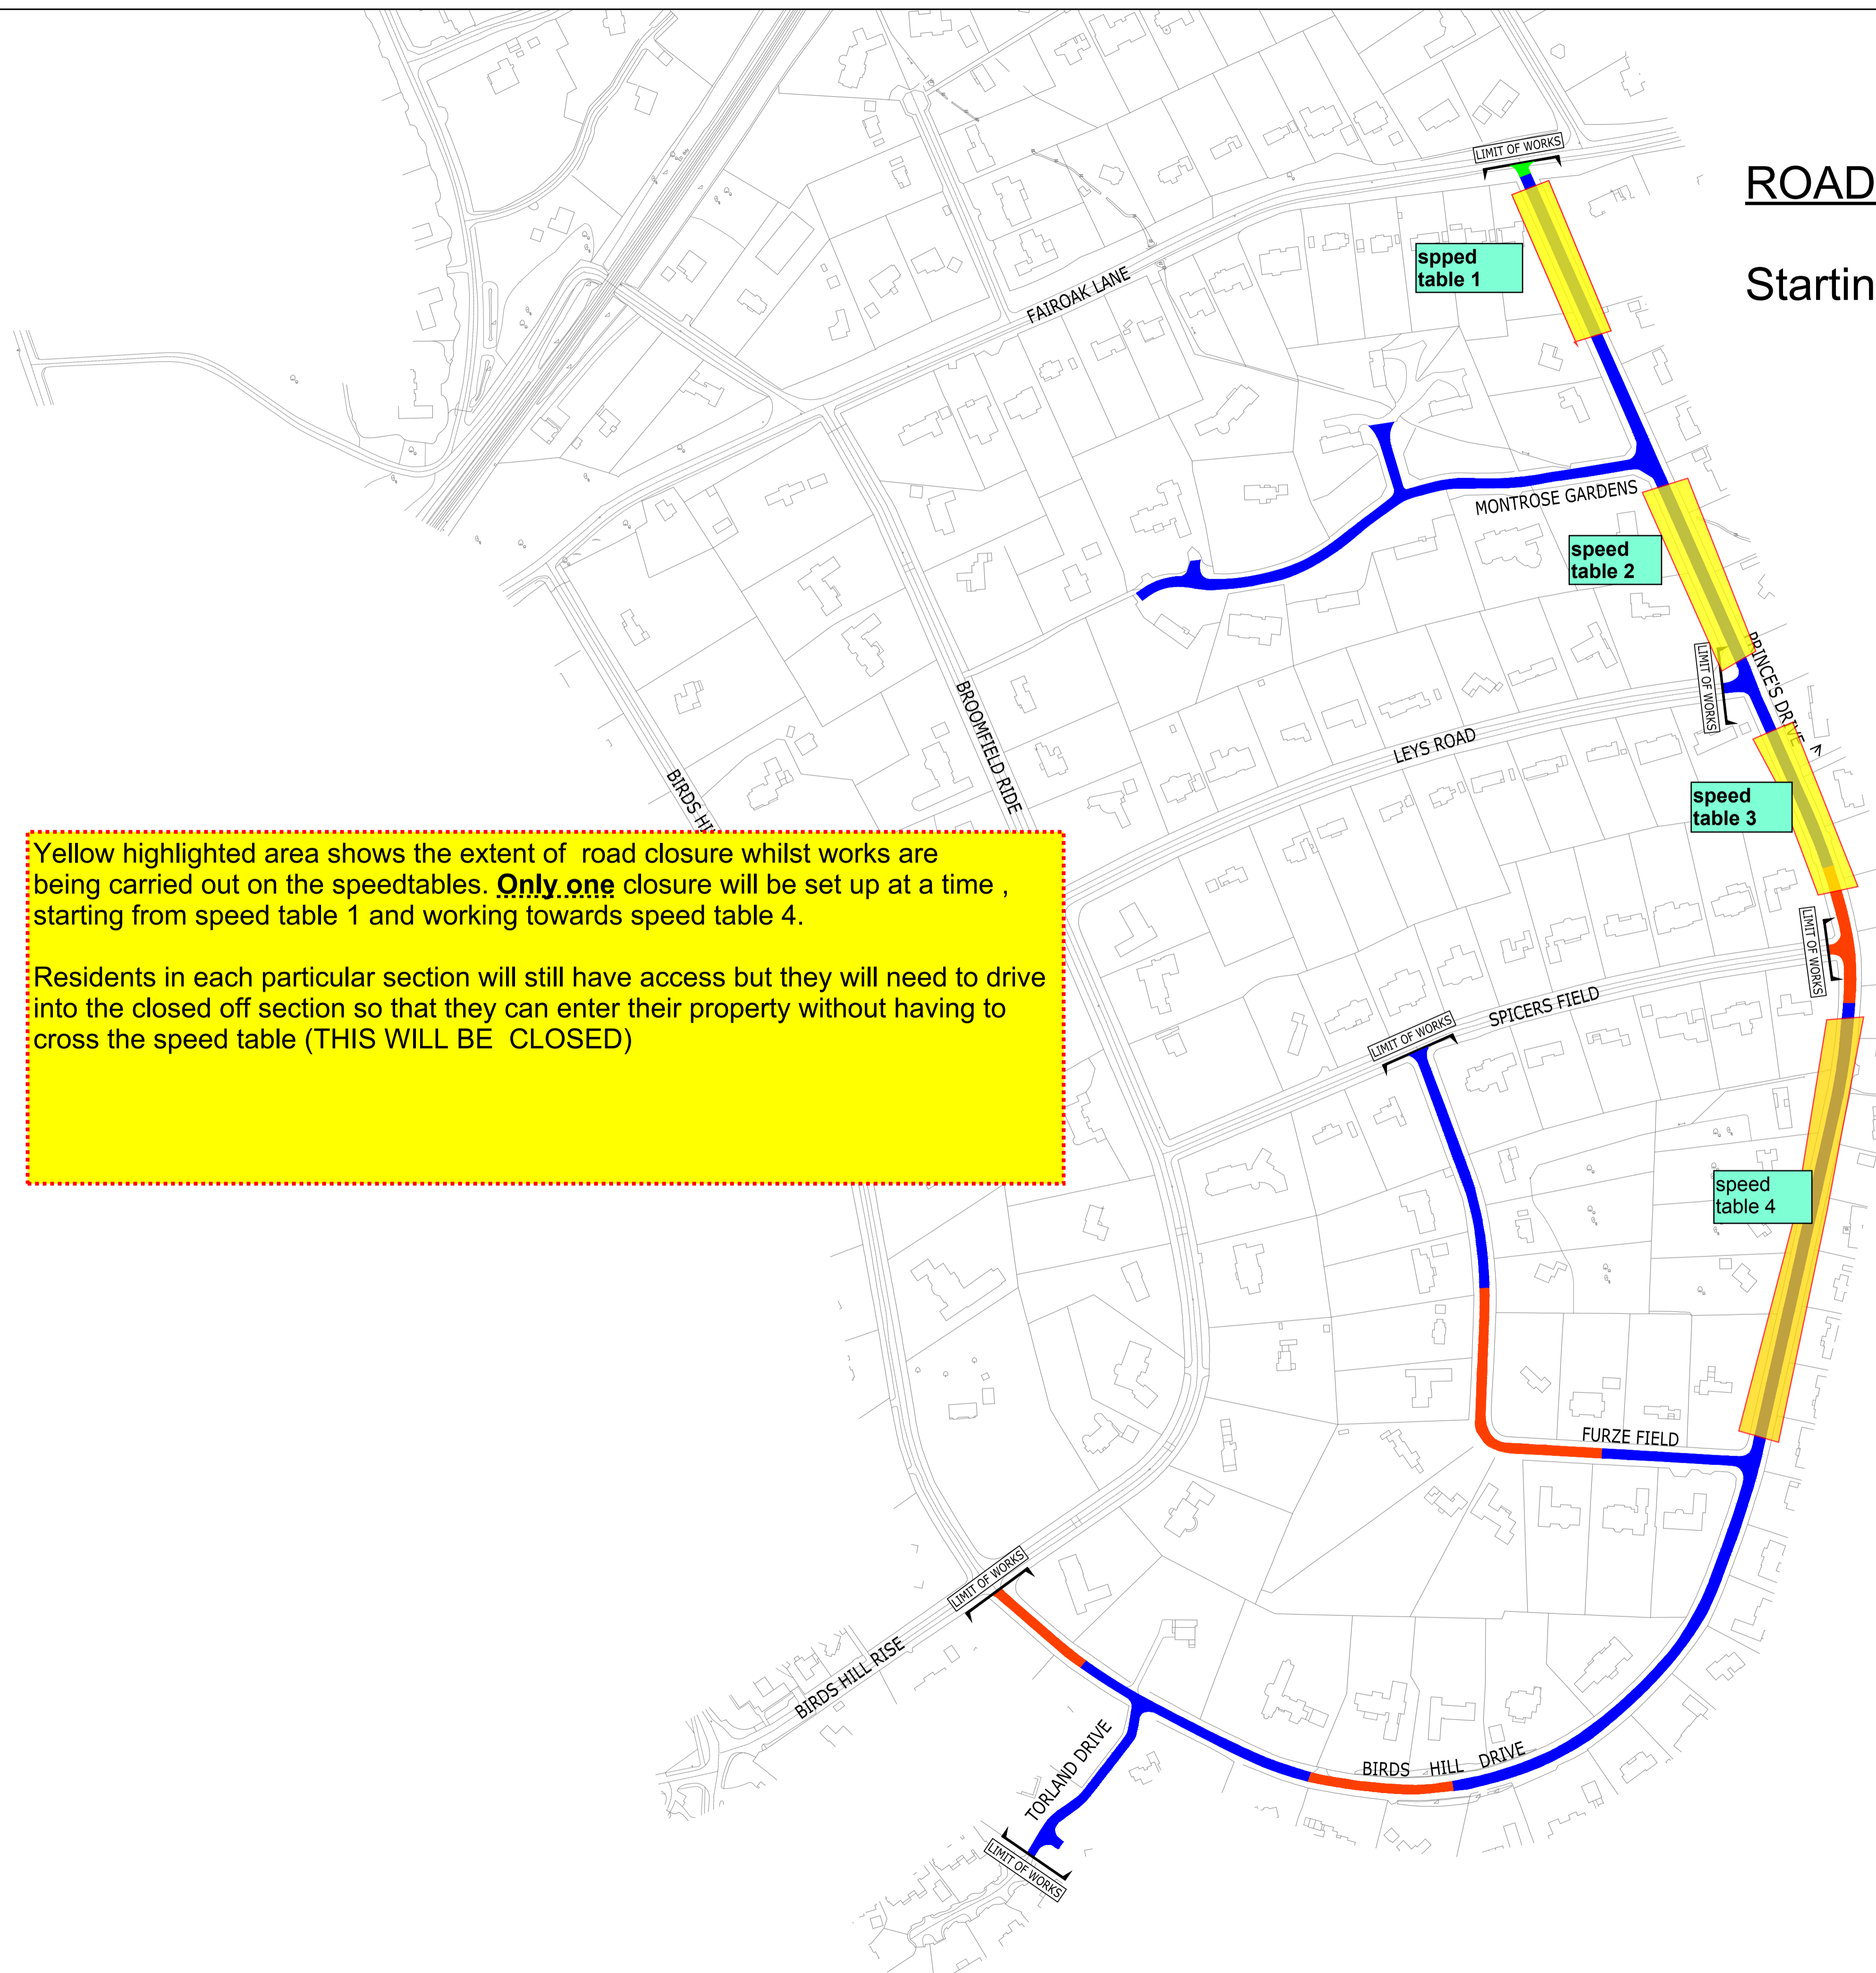

- Notes
- THIS DRAWING IS NOT TO BE SCALED.
 - THIS IS NOT AN INSTALLATION DRAWING NOR A CO-ORDINATION DRAWING.
 - THIS DRAWING IS BASED ON:
 - OS PLAN AS PROVIDED BY THE CLIENT.
 - REFER TO DRAWINGS:
 - 31577/C/000-004 FOR EXISTING SERVICES.
 - 31577/C/050-054 FOR SITE CLEARANCE LAYOUT.
 - 31577/C/100-105 FOR DRAINAGE WORKS.
 - 31577/C/500-504 FOR PROPOSED KERBS AND GENERAL ARRANGEMENT.
 - 31577/C/510 FOR CONSTRUCTION AREAS PLAN.
 - 31577/C/511 FOR STREET LIGHTING LAYOUT.
 - 31577/C/550-551 FOR CONSTRUCTION DETAILS.
 - REFER TO DRAWING 31577/C/550 FOR DETAILS OF THE TIE-IN WITH EXISTING CARRIAGEWAY PAVEMENT CONSTRUCTION.

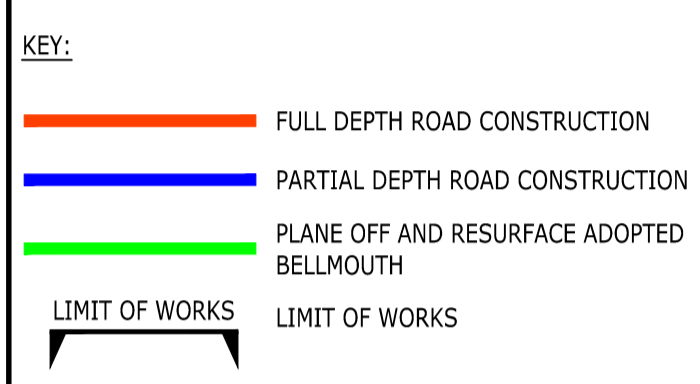

© Crown Copyright 2008. All rights reserved.
Licence number 100020449

T01	ISSUE FOR TENDER	10.09 2013	DM SP	PEP
Rev	Description	Date	By Chk	App

TENDER

OXSHOTT ESTATE ROAD MANAGEMENT - SOUTH SIDE

tel 020 7631 5291 fax 020 7323 4645 london@ramboll.co.uk www.ramboll.co.uk

CONSTRUCTION AREAS PLAN
PHASE 1

Scale:	Date:	Drawn:	Checked:
1:2000 @ A1	JUN 2013	DM	SP
Drawing No.:	Rev:		
31577/C/510	T01		